


Luminaire Schedule

Symbol	Qty	Label	Arrangement	Total Lamp Lumens	h/LF	Description
—•	3	ge177231_tcm201-58282	SINGLE	8000	0.790	M2AR15S_AMS3

Calculation Summary

Label	CalcType	Units	Avg	Max	Min	Avg/Min	Max/Min
1535 67 W Main St_Top_1	Illuminance	Fc	0.45	1.0	0.0	N.A.	N.A.

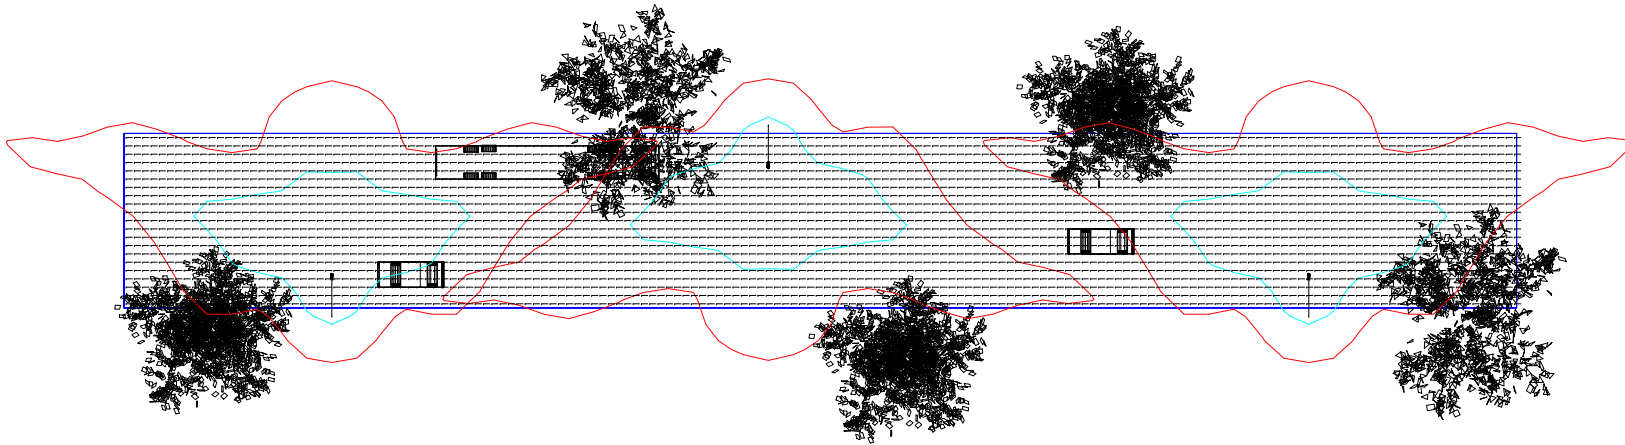

Revisions	Date	Comments
#		


Drawn By: SSX	Checked By:	Date: 5/5/2014	Scale: NTS
---------------	-------------	----------------	------------

1535 West Main Street	Mercury Vapor
-----------------------	---------------



Luminaire Schedule						
Symbol	Qty	Label	Arrangement	Total Lamp Lumens	h/LF	Description
→	3	SVS-35W16LED4K-T-LE2 (S1	SINGLE	N.A.	0.900	SVS-35W16LED4K-T-LE2-UNIV

Calculation Summary							
Label	CalcType	Units	Avg	Max	Min	Avg/Min	Max/Min
1535 67 W Main St_Top_1	Illuminance	Fc	0.49	1.1	0.0	N.A.	N.A.

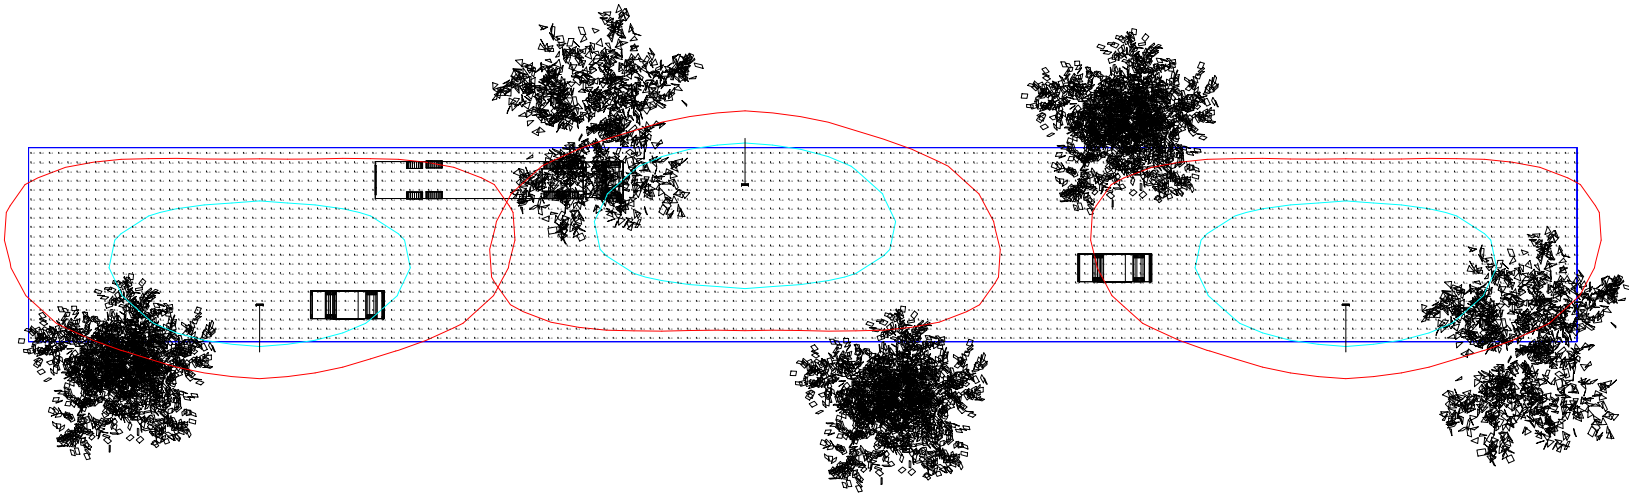

Revisions		Date	Comments
#			


Drawn By: SSX	Checked By:	Date: 5/5/2014	Scale: NTS
---------------	-------------	----------------	------------

1535 West Main Street	LED
-----------------------	-----



Luminaire Schedule						
Symbol	Qty	Label	Arrangement	Total Lamp Lumens	SLF	Description
—■	3	ge177231_tcm201-58282	SINGLE	8000	0.790	M2AR15S_AMS3_


Calculation Summary							
Label	CalcType	Units	Avg	Max	Min	Avg/Min	Max/Min
1754 Sterigere St_Top_1	Illuminance	Fc	0.46	1.0	0.0	N.A.	N.A.

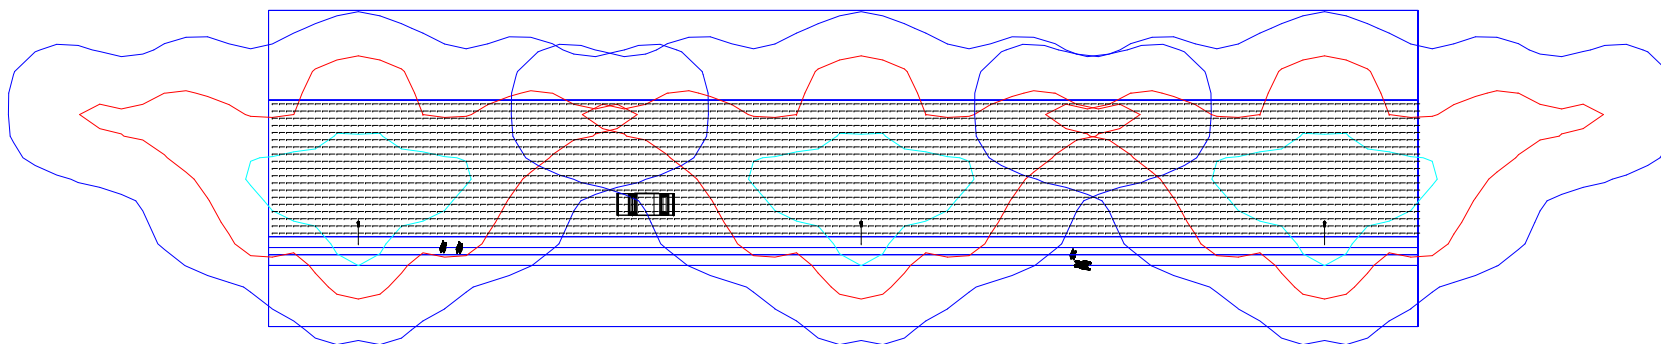

Revisions		Date	Comments
#			

Drawn By: SSX	Checked By:	Date: 5/5/2014	Scale: NTS
---------------	-------------	----------------	------------

1754 Sterigere St.	
Mercury Vapor	

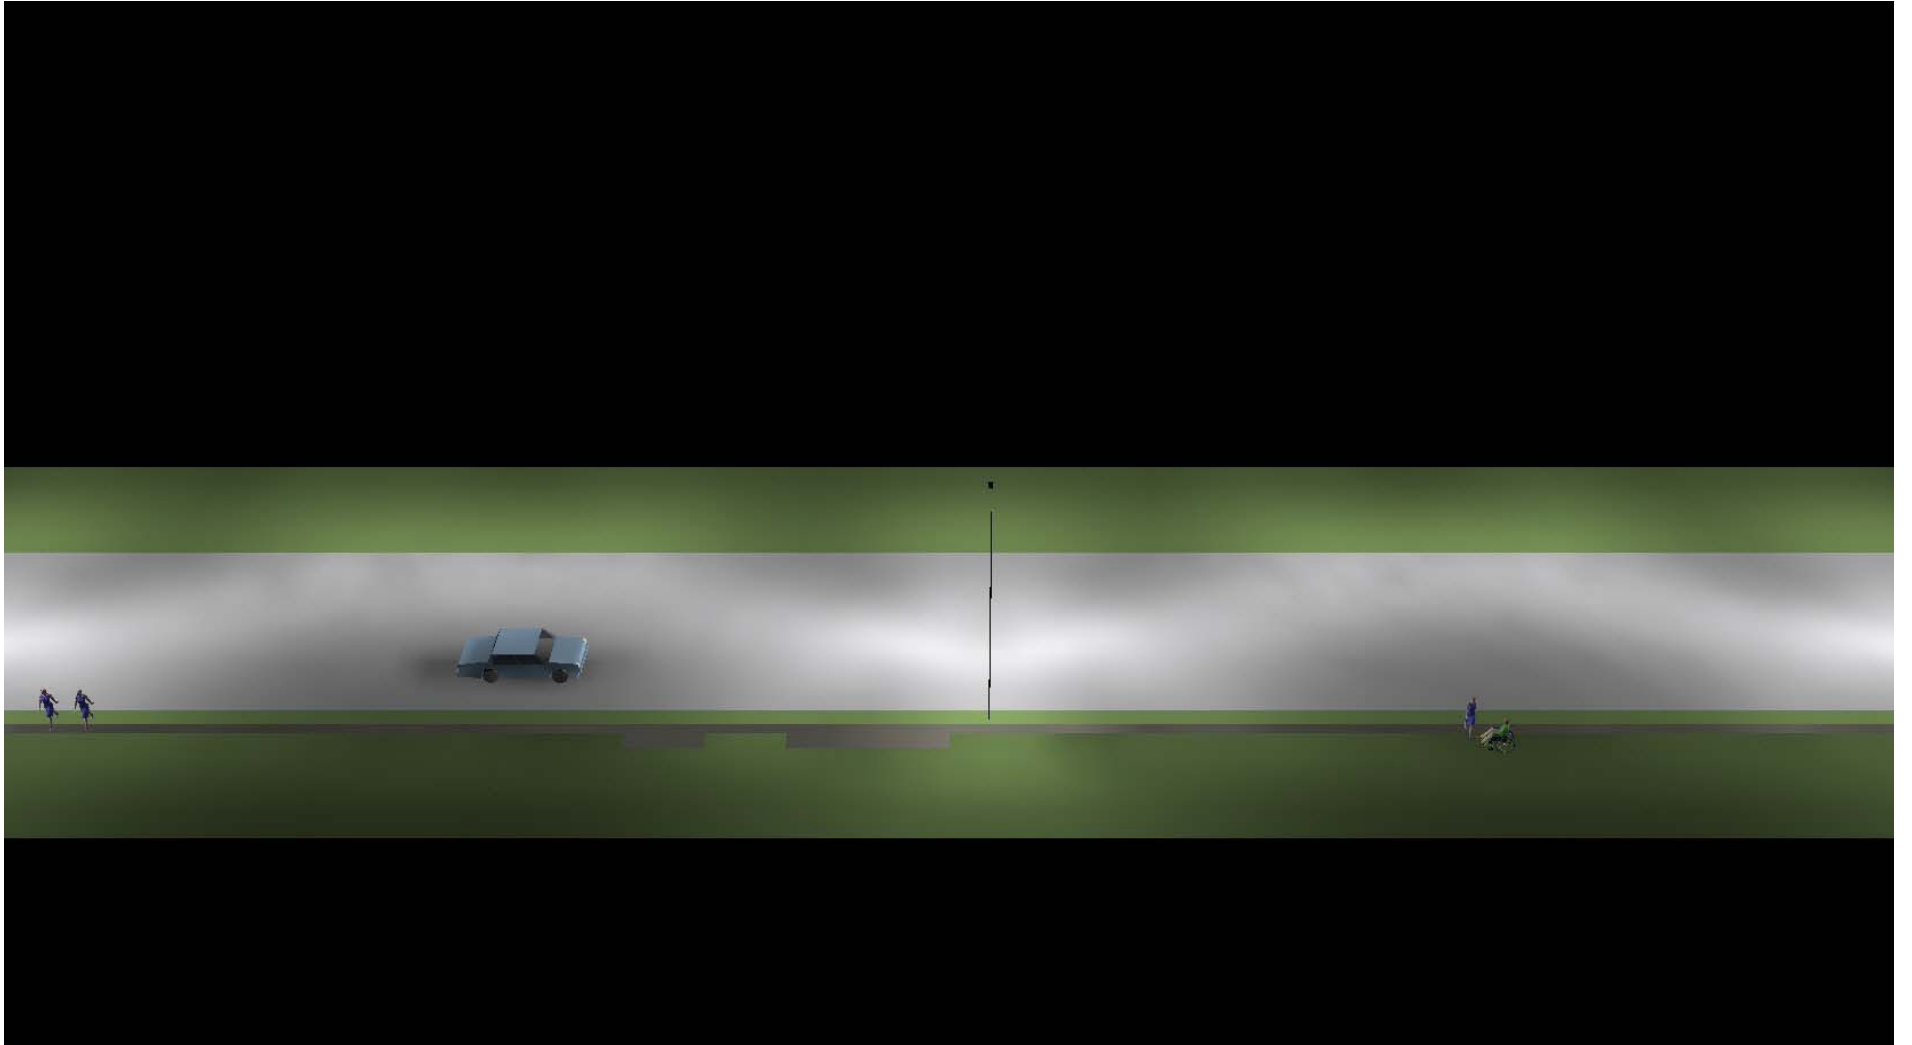


Luminaire Schedule

Symbol	Qty	Label	Arrangement	Total Lamp Lumens	SLF	Description
—	3	SVS-35W16LED4K-T-LE2 (S1	SINGLE	N.A.	0.900	SVS-35W16LED4K-T-LE2-UNIV

Calculation Summary


Label	CalcType	Units	Avg	Max	Min	Avg/Min	Max/Min
1754 Sterigere St_Top_1	Illuminance	Fc	0.50	1.0	0.0	N.A.	N.A.

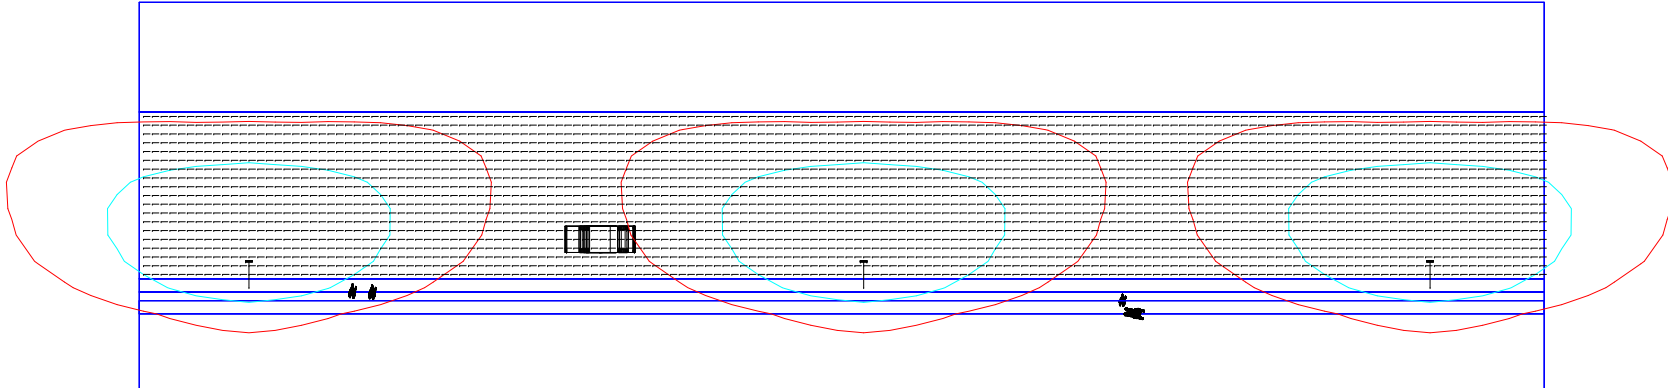

Revisions	#	Date	Comments


Drawn By: SSX	Checked By:	Date: 5/5/2014	Scale: NTS
---------------	-------------	----------------	------------

1754 Sterigere St.	LED
--------------------	-----

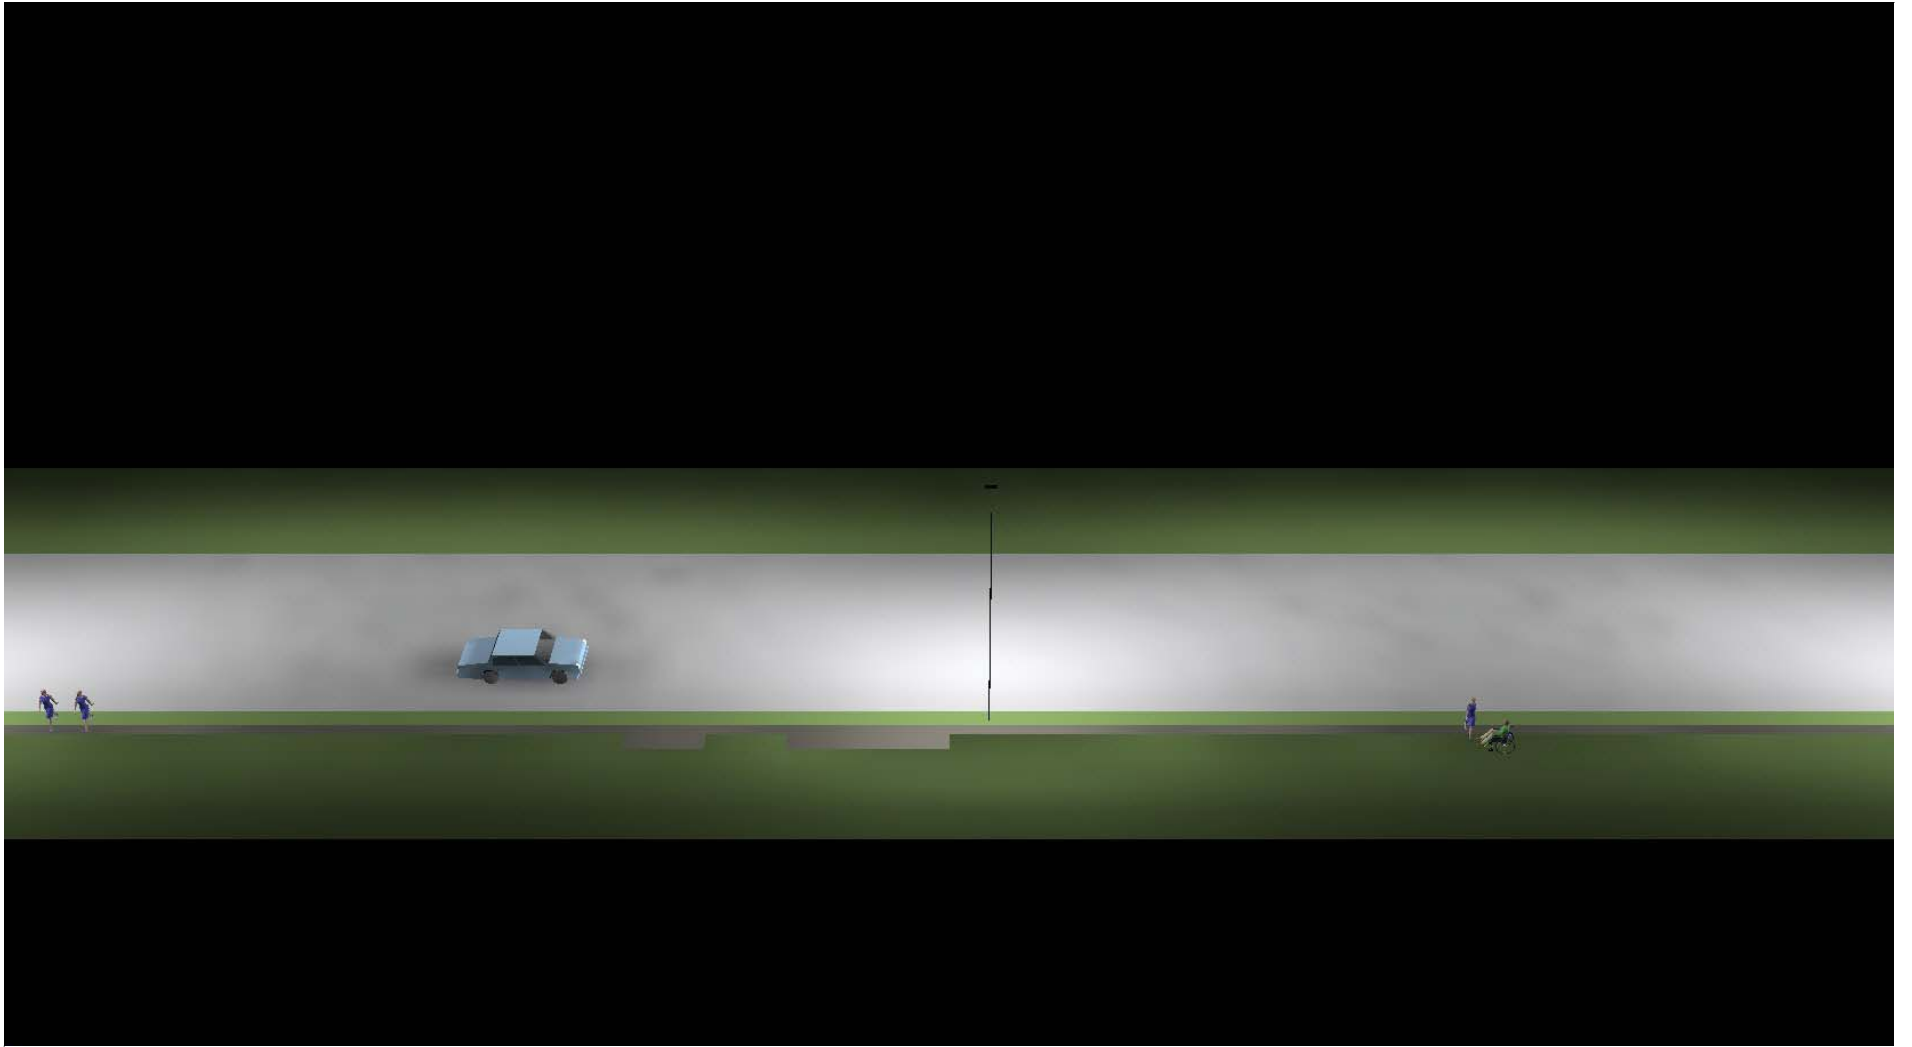

Luminaire Schedule					
Symbol	Qty	Label	Arrangement	Total Lamp Lumens	Description
—■	3	ge177231_tcm201-58282	SINGLE	8000	M2AR15S_AMS3


Calculation Summary							
Label	CalcType	Units	Avg	Max	Min	Avg/Min	Max/Min
2121 Hemlock Rd_Top_1	Illuminance	Fc	0.58	1.8	0.0	N.A.	N.A.

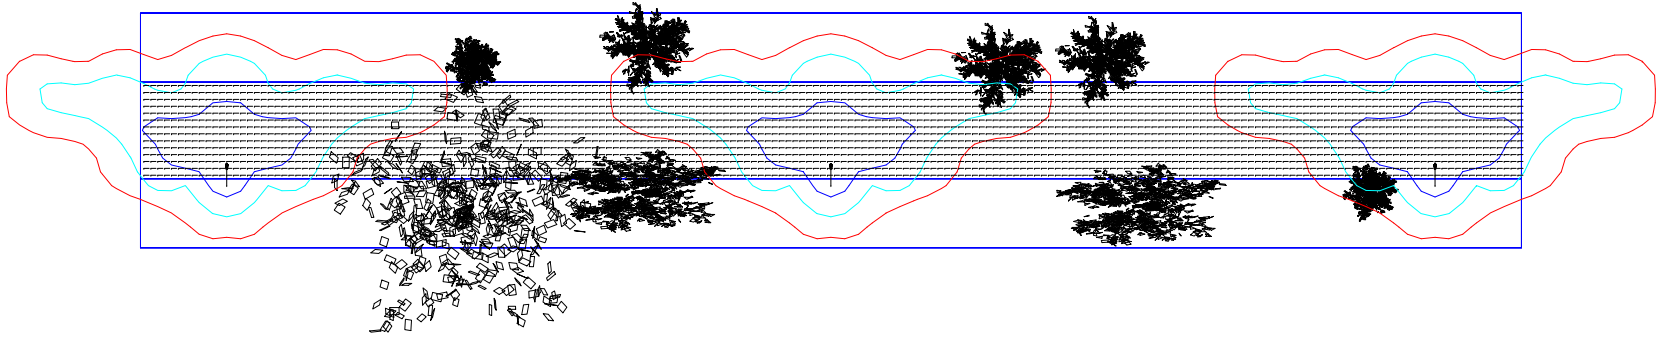

Revisions		
#	Date	Comments


Drawn By: SSX
Checked By:
Date: 5/5/2014
Scale: NTS

2121 Hemlock Rd.
Mercury Vapor

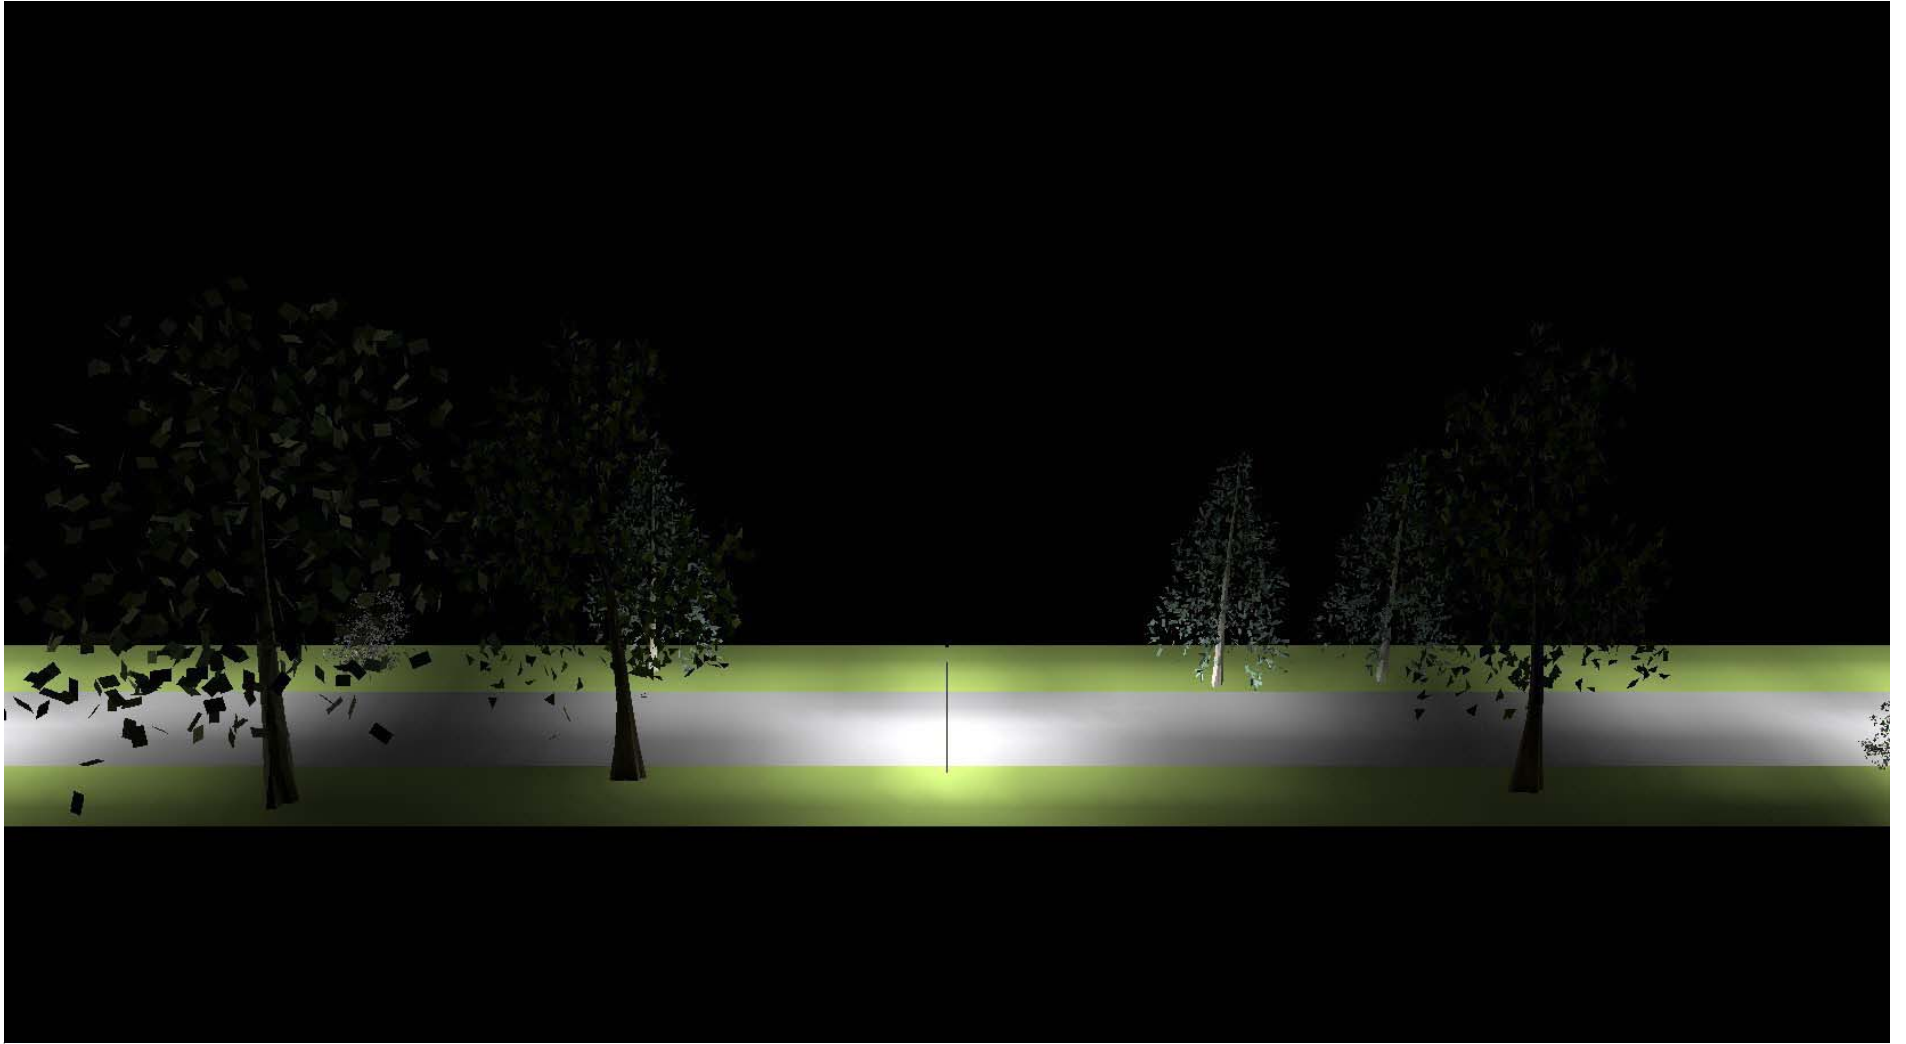

Luminaire Schedule						
Symbol	Qty	Label	Arrangement	Total Lamp Lumens	SLF	Description
—	3	SVS-35W16LED4K-T-LE2 (S1	SINGLE	N.A.	0.900	SVS-35W16LED4K-T-LE2-UNIV


Calculation Summary							
Label	CalcType	Units	Avg	Max	Min	Avg/Min	Max/Min
2121 Hemlock Rd_Top_1	Illuminance	Fc	0.63	2.0	0.1	6.30	20.00

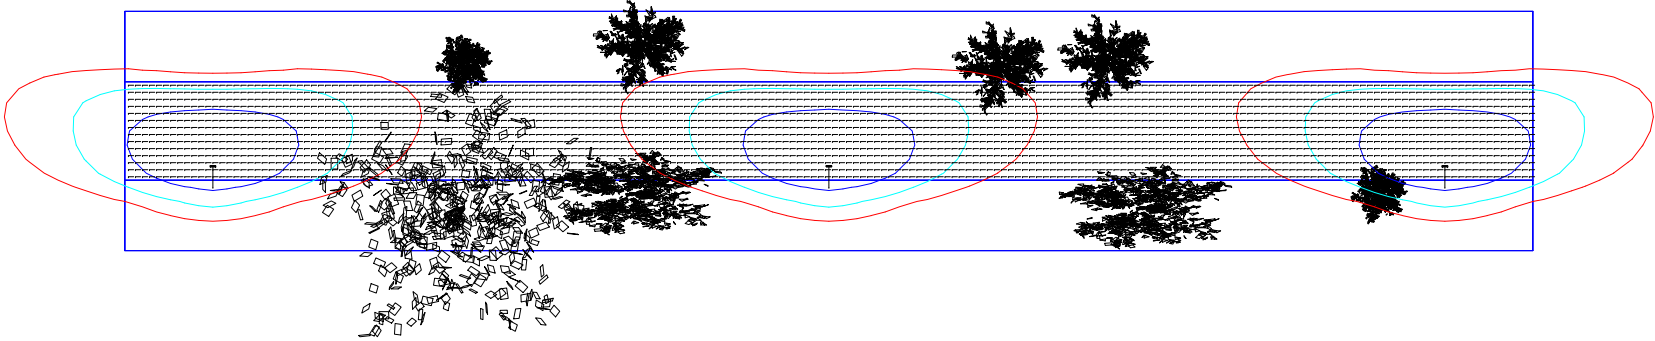

Revisions		Date	Comments
#			


Drawn By: SSX	Checked By:
Date: 5/5/2014	Scale: NTS

2121 Hemlock Rd.	LED
------------------	-----

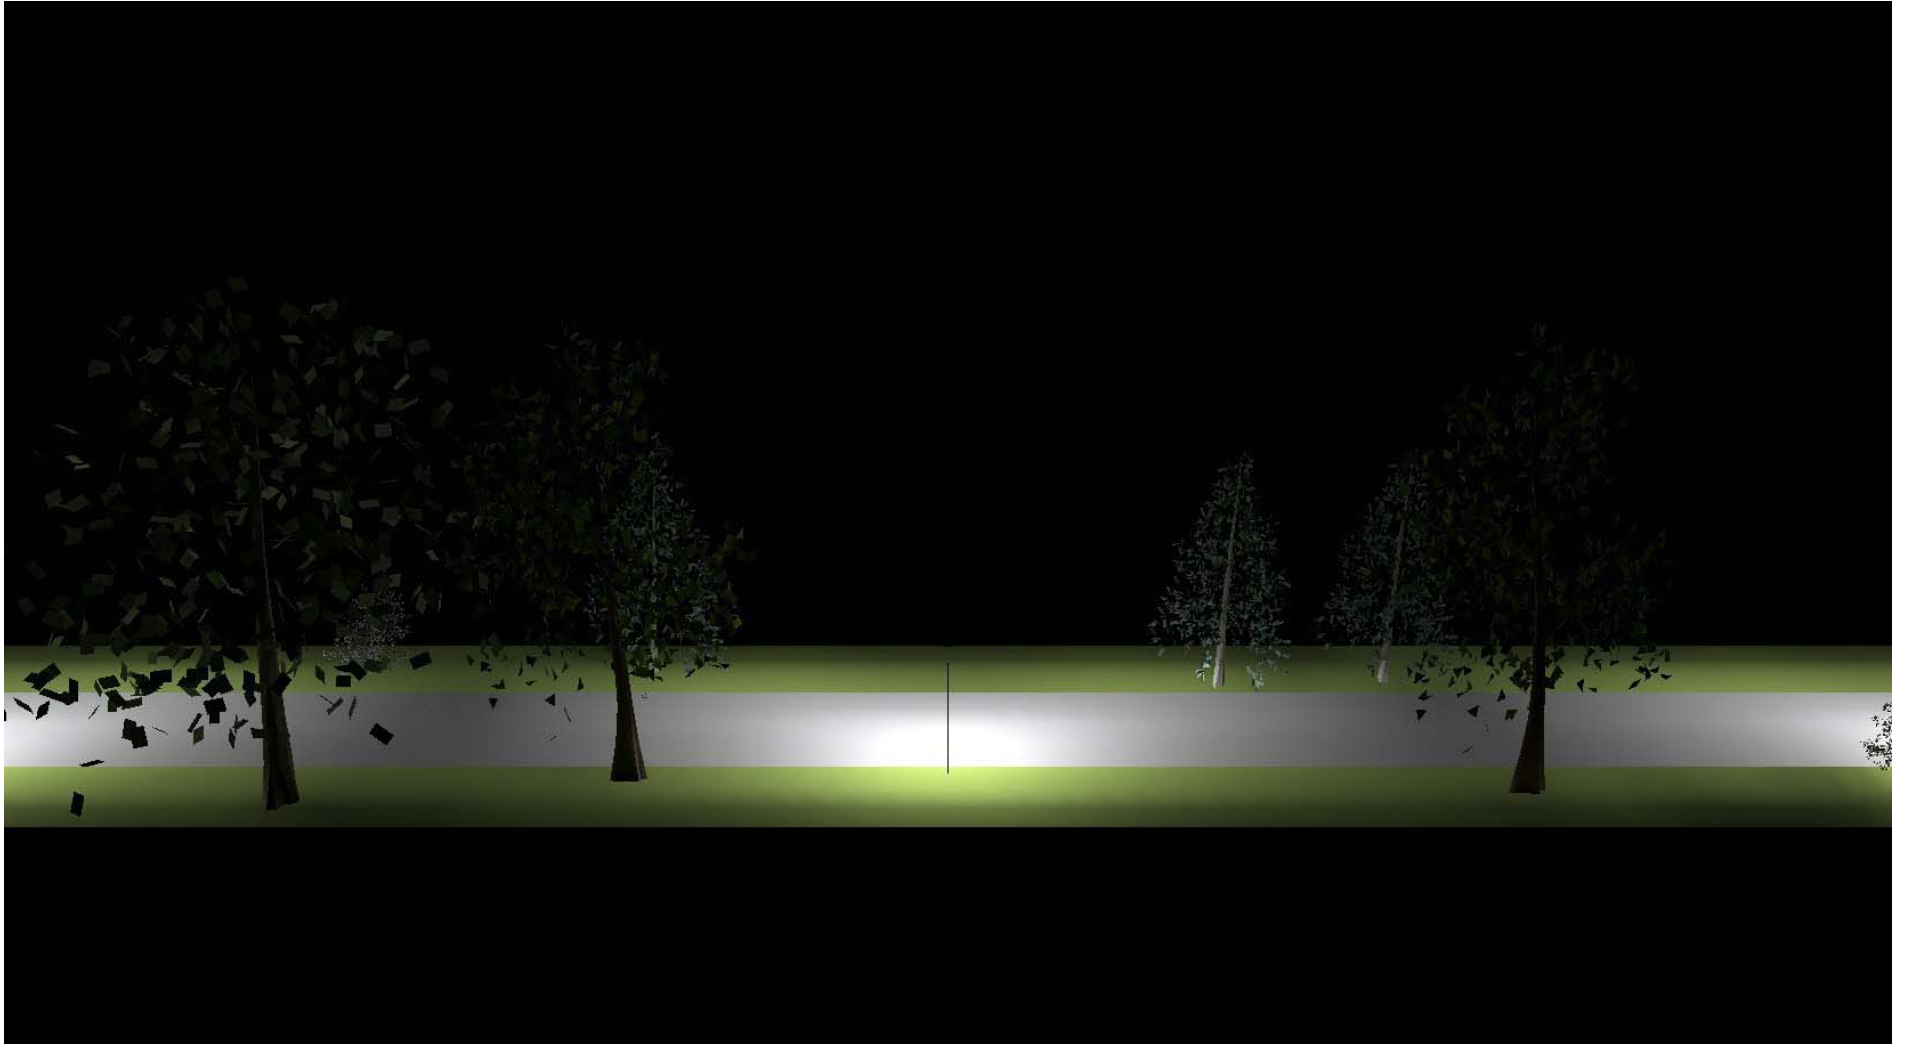

Luminaire Schedule					
Symbol	Qty	Label	Arrangement	Total Lamp Lumens	Description
—•	3	ge177231_tcm201-58282	SINGLE	8000	M2AR15S_AMS3_

Calculation Summary							
Label	CalcType	Units	Avg	Max	Min	Avg/Min	Max/Min
2213 W Main St_Top_1	Illuminance	Fc	0.64	2.0	0.0	N.A.	N.A.

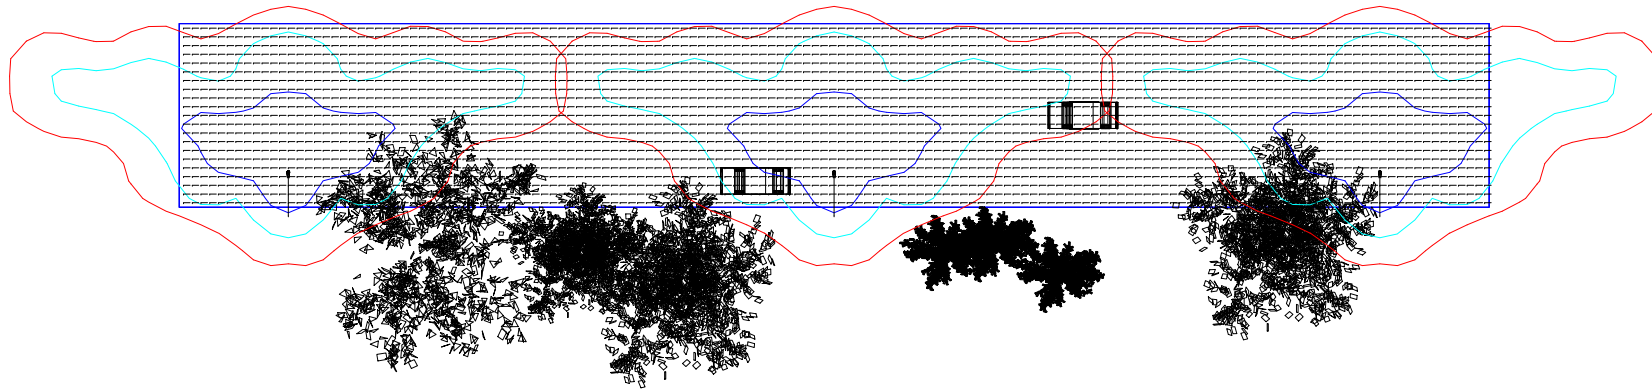

Revisions		Date	Comments
#			


Drawn By: SSX	Checked By:	Date: 5/5/2014	Scale: NTS
---------------	-------------	----------------	------------

2213 W. Main St.	Mercury Vapor
------------------	---------------



Luminaire Schedule						
Symbol	Qty	Label	Arrangement	Total Lamp Lumens	SLF	Description
—→	3	SVS-35W16LED4K-T-LE2 (S1	SINGLE	N.A.	0.900	SVS-35W16LED4K-T-LE2-UNIV

Calculation Summary							
Label	CalcType	Units	Avg	Max	Min	Avg/Min	Max/Min
2213 W Main St_Top_1	Illuminance	Fc	0.64	2.2	0.0	N.A.	N.A.

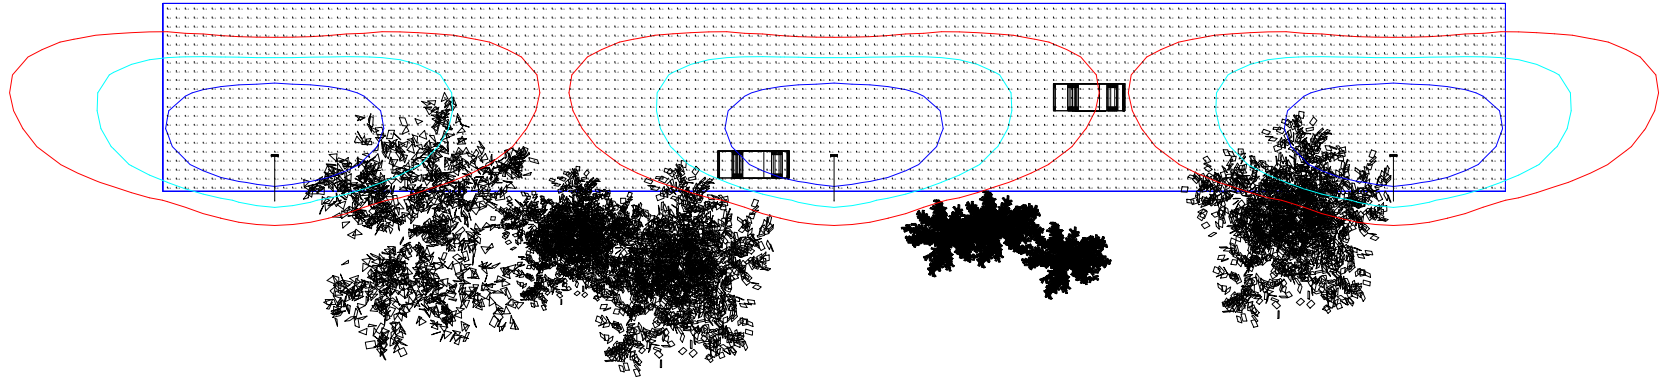

Revisions		Comments
#	Date	

Drawn By: SSX	Checked By:	Date: 5/5/2014	Scale: NTS
---------------	-------------	----------------	------------

2213 W. Main St.	Mercury Vapor
------------------	---------------

